



① FOUNDATION PLAN — LIBRARY  
SCALE 1/8" = 1'-0"

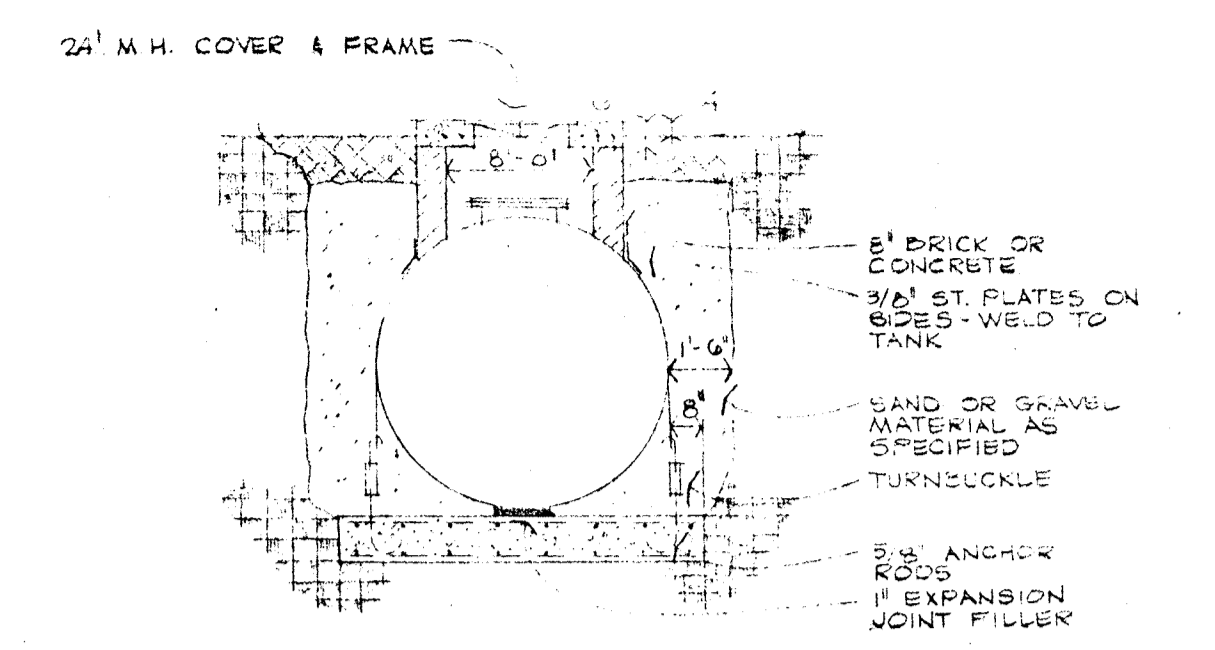

SECTION A-A

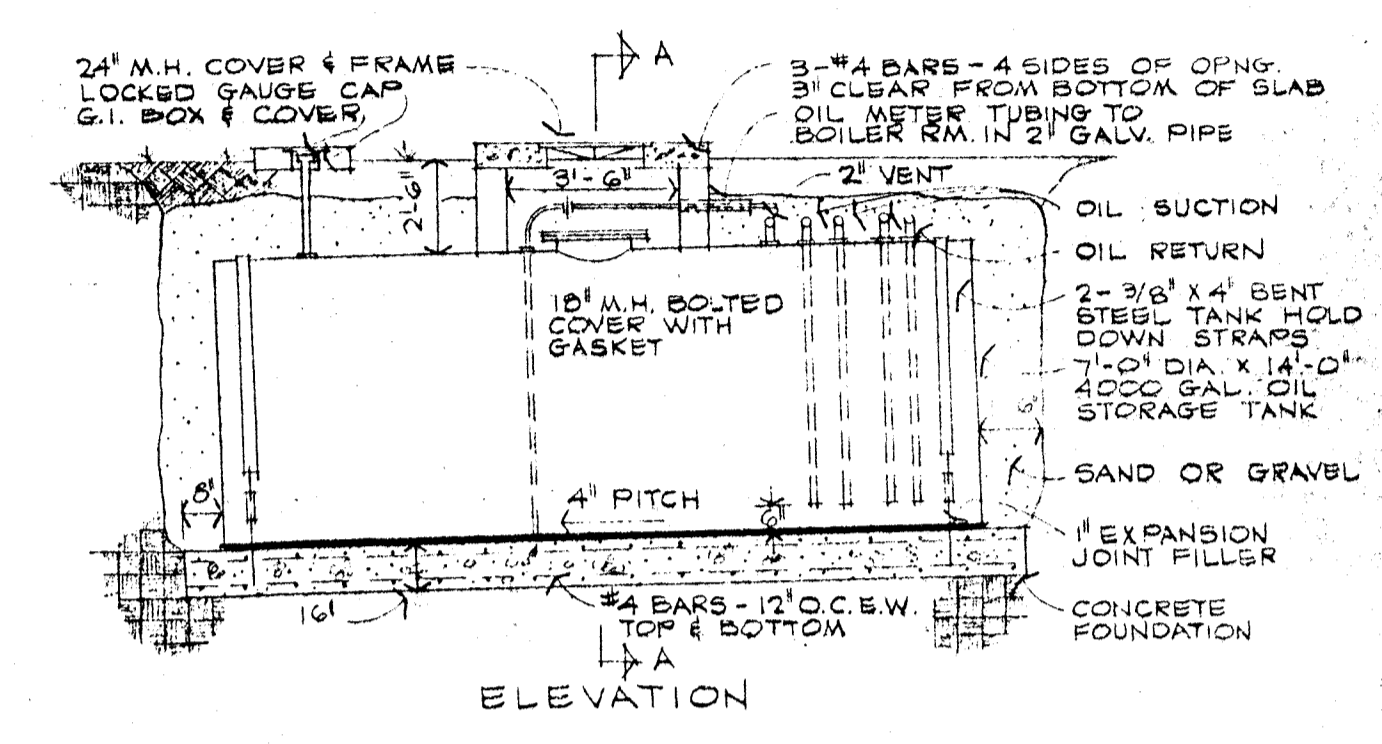

ELEVATION

② OIL STORAGE TANK DETAIL  
NO SCALE  
M-4

HUMANITIES & INSTRUCTIONAL MEDIA CENTERS		7080
STATE JUNIOR COLLEGE		
FERGUS FALLS, MINNESOTA		
Kegel Associates ARCHITECTS DETROIT LAKES, MINNESOTA	DRAWN: AGNER, LUBETZ	M4
	CHECKED: MOONEY	
	AUGUST 1970	